



SANITARY ISOMETRIC PLAN  
SCALE: 3/16" = 1'-0"

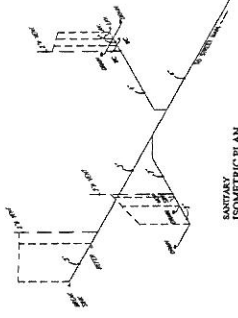

SANITARY ISOMETRIC PLAN  
SCALE: 3/16" = 1'-0"

GENERAL NOTES:  
 1. ALL SUPPLY LINES TO FIXTURES TO BE 1/2" P.P.E. UNLESS NOTED OTHERWISE.  
 2. BUILDING SANITARY MAIN SHALL HAVE A SLOPE OF 1/8" PER 1'-0" OF PIPE.  
 3. ALL BACK ROOF PENETRATIONS TO BE BLACK-ROOF TYPE UNLESS NOTED OTHERWISE.  
 4. ALL VENT PIPING TO BE 1/2" UNLESS OTHERWISE NOTED.

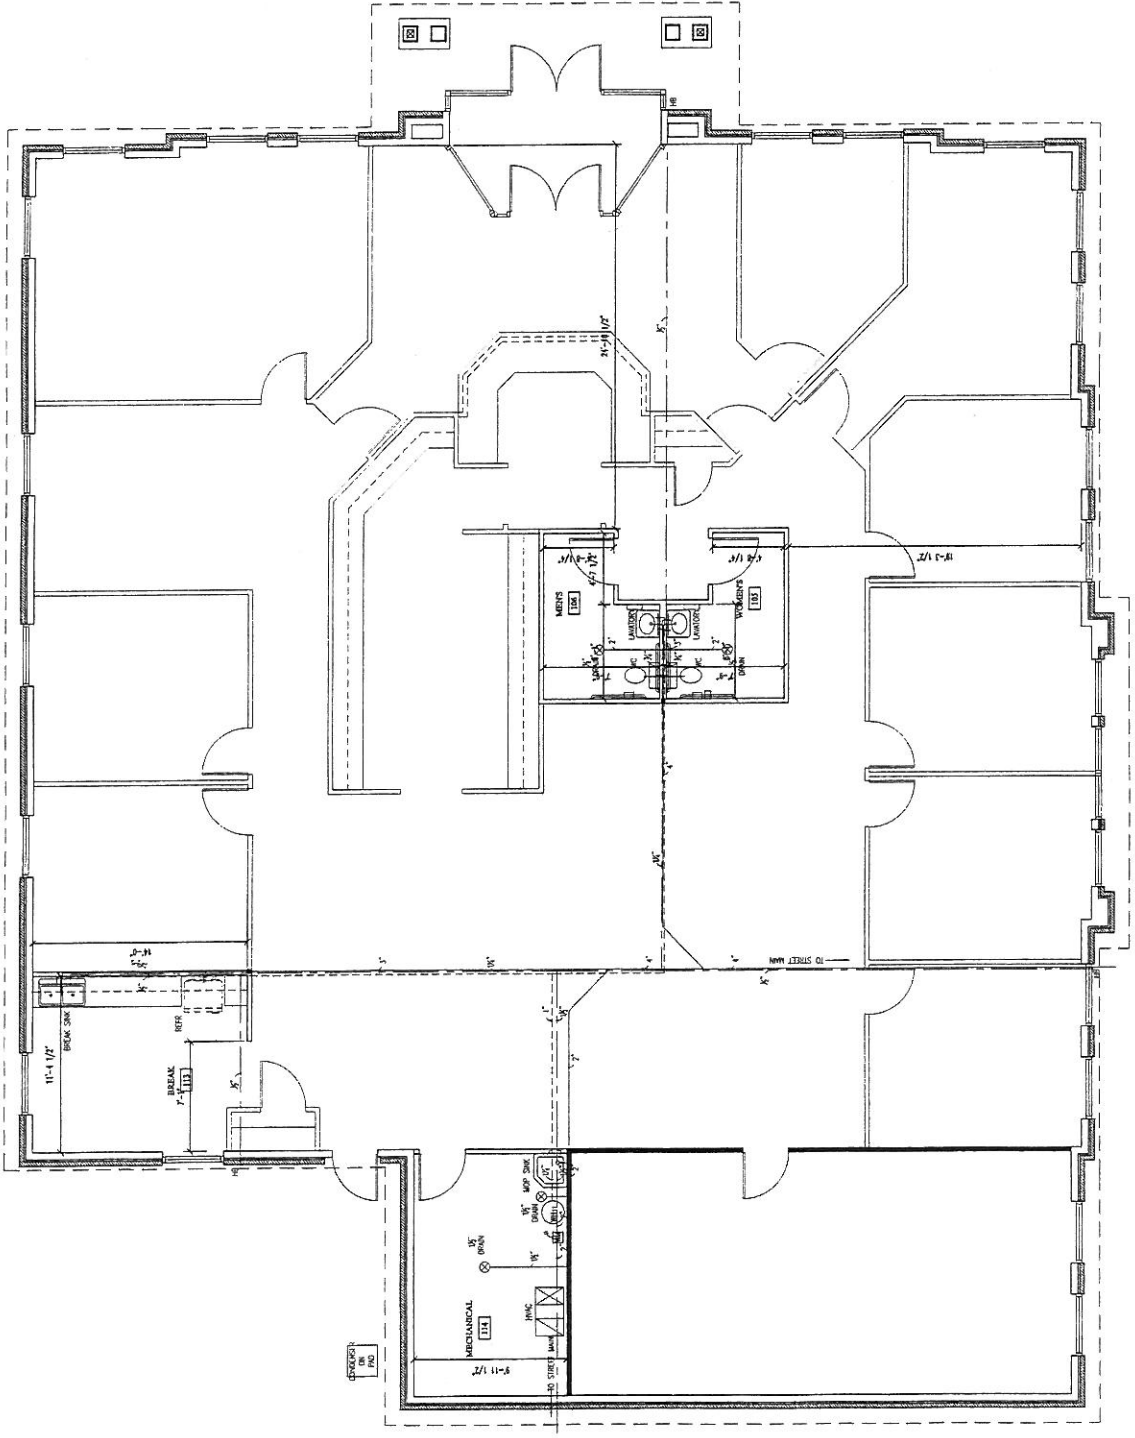

SUPPLY & SANITARY PLUMBING PLAN  
SCALE: 1/4" = 1'-0"

